


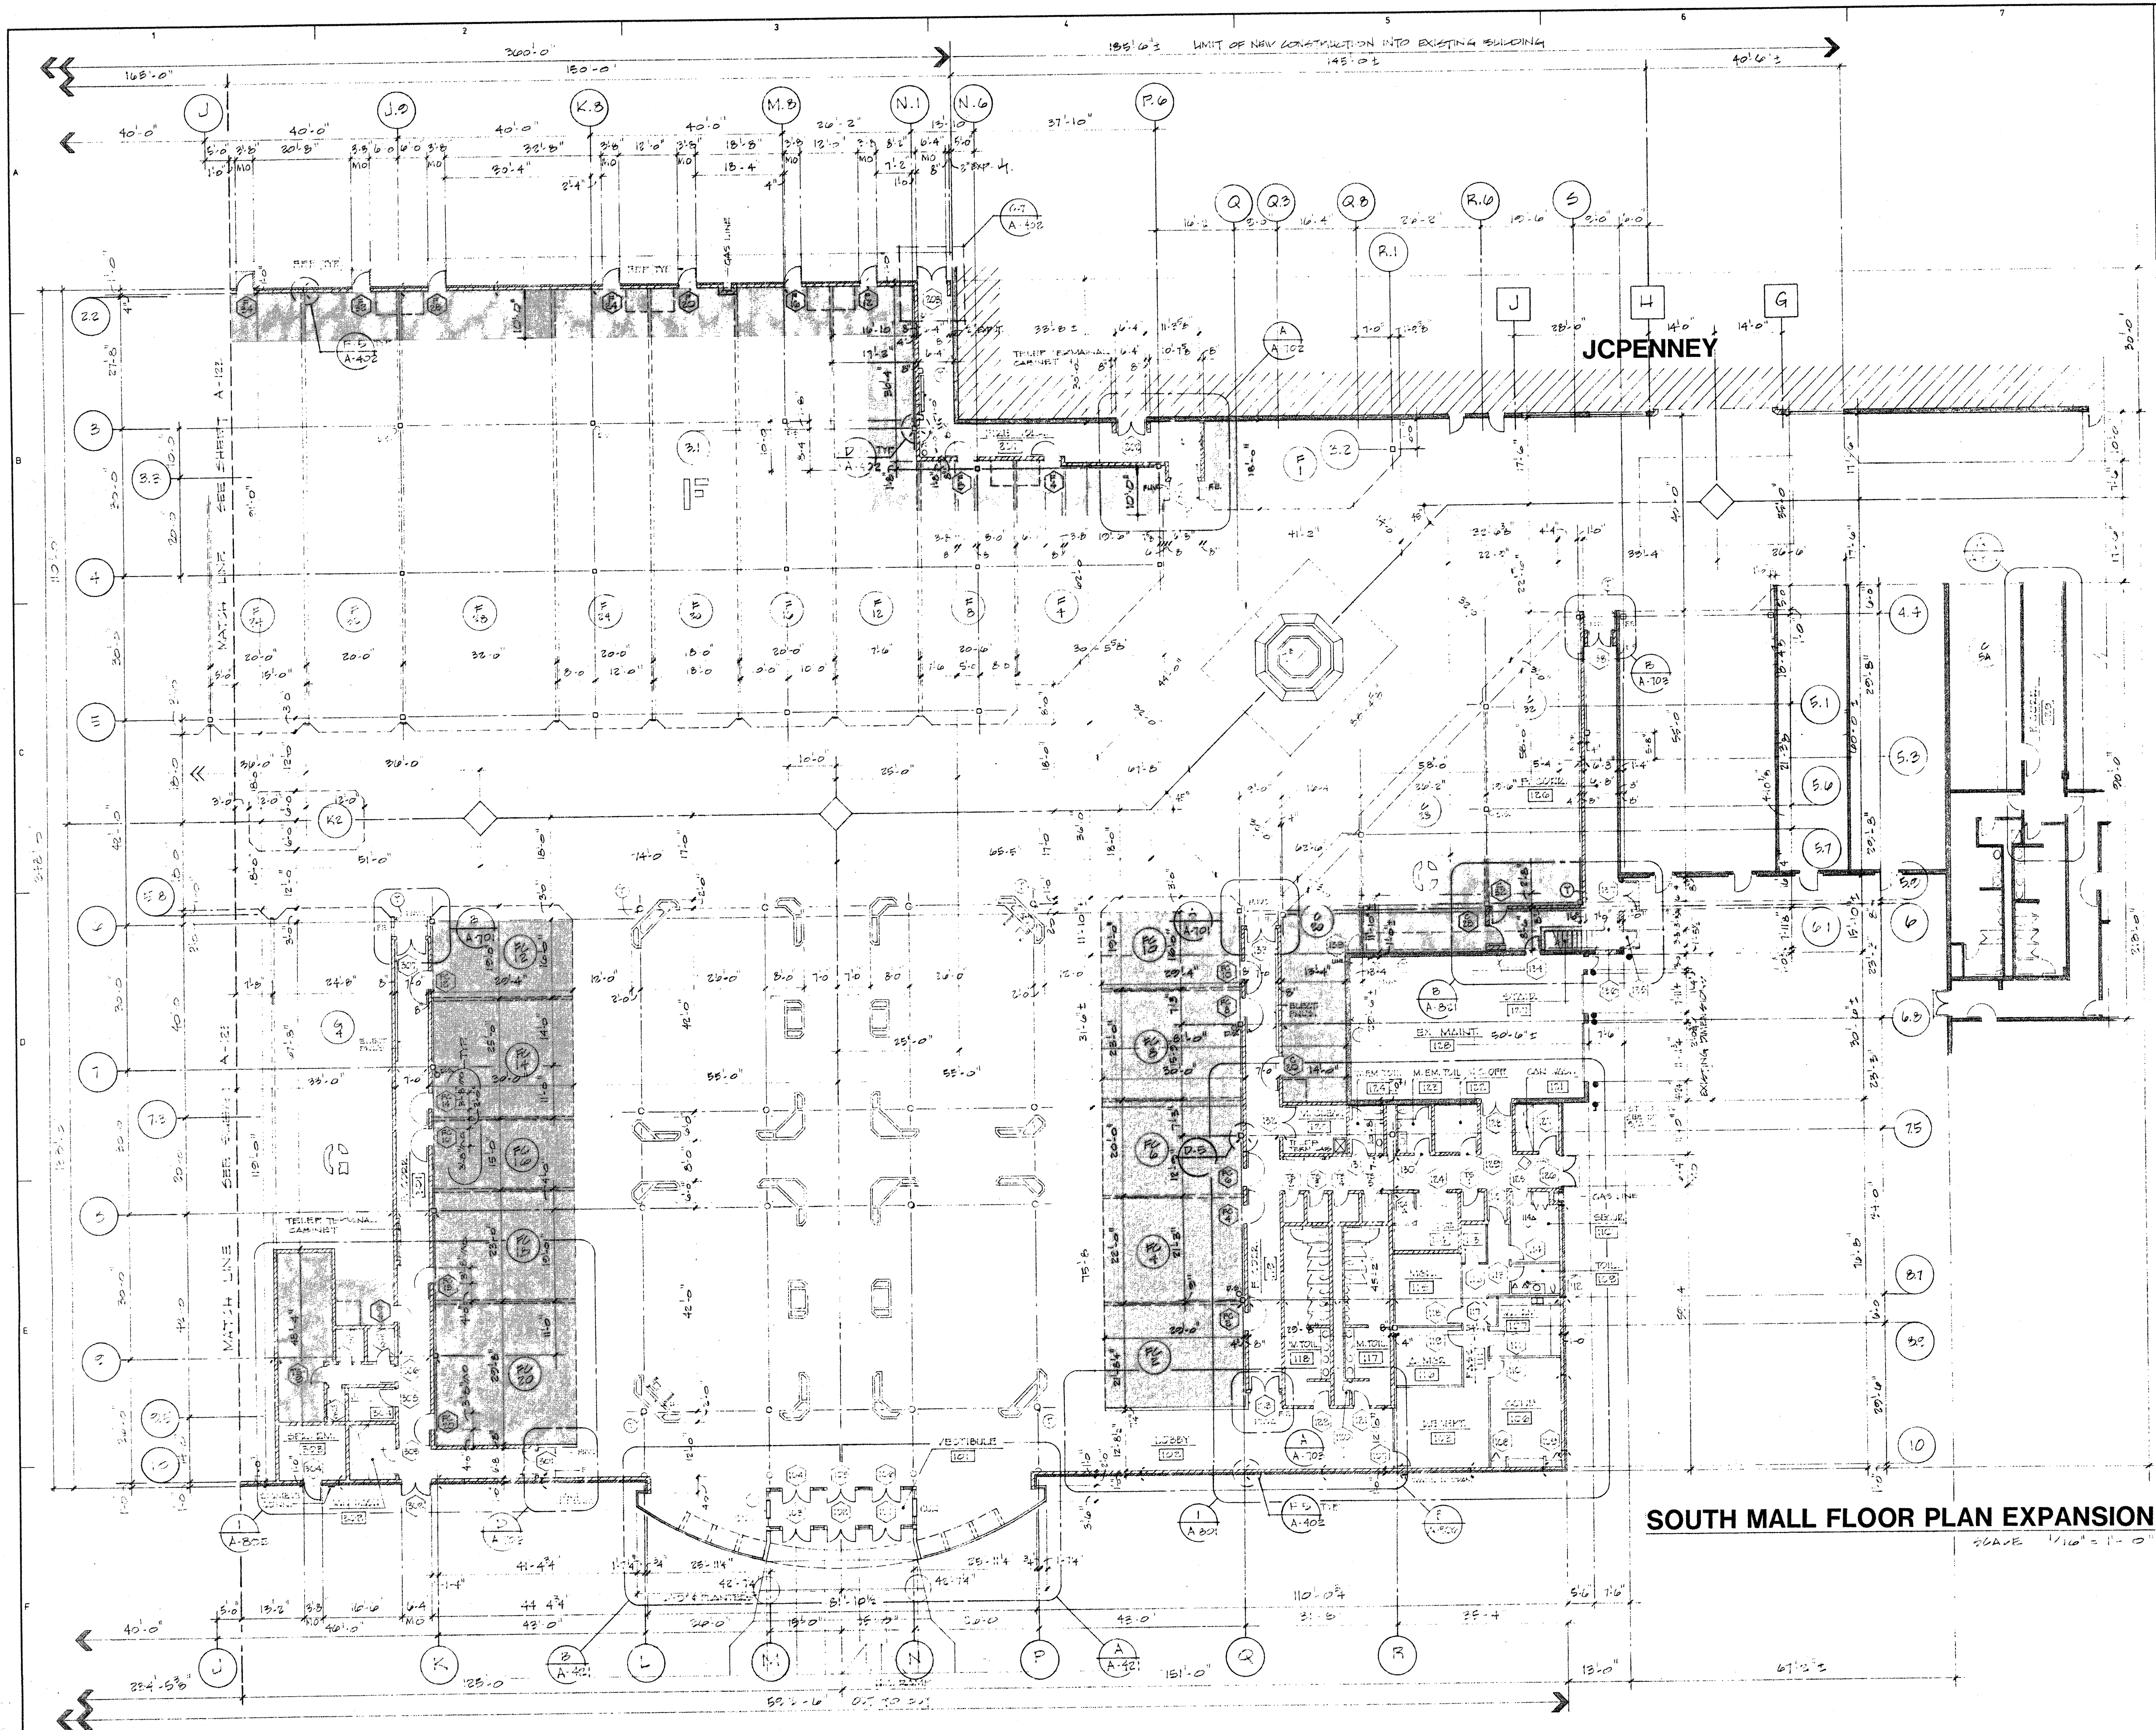

SOUTH MALL FLOOR PLAN EXPANSION

SCALE: 1/16" = 1' - 0"

"KEYNOTE SYSTEM IN DRAWINGS"

A keynoting system is used on the architectural drawings for material references and notes. Refer to the keynote legend on the drawing for the information which relates to each keynote on that respective drawing.

Each keynote consists of a 5-digit number followed by a period and a letter or letter/number suffix. The 5-digit number relates to the specification section which generally covers the item that is referenced and the suffix identifies the specific reference notation used on the drawings. The suffix does not relate to any corresponding reference letter in the specifications.

THE ORGANIZATION OF THE KEYNOTING SYSTEM ON THE DRAWINGS, WITH THE KEYNOTE REFERENCE NUMBERS RELATED TO THE SPECIFICATIONS SECTIONS NUMBERING SYSTEM, SHALL NOT CHANGE. THE GENERAL CONTRACTOR IN DIVIDING THE WORK AMONG ITS SUBCONTRACTORS OR IN ESTABLISHING THE EXTENT OF WORK TO BE PERFORMED BY ANY ONE TRADE.

REVISIONS	
1	BULLETIN No. 4 10-11-89

[Signature]

**MIDWAY MALL
EXPANSION**
ELYRIA, OHIO

CENTER RIDGE DESIGN SERVICES INC. P.A.
ARCHITECTS - ENGINEERS
2425 CENTER RIDGE ROAD
CLEVELAND, OHIO 44122
Area Code 216 871-4000

SOUTH MALL FLOOR PLAN

BUILDINGS 'C', 'F' AND 'G'
FOOD COURT

JACOBS, VISCONSI & JACOBS CO.
DEVELOPERS - MANAGERS



2425 CENTER RIDGE ROAD
CLEVELAND, OHIO 44122
Area Code 216 871-4000

KEY PLAN

Diagram showing the location of the South Mall Floor Plan Expansion within the larger context of the Midway Mall project, including labels for 'SEARS', 'JCPENNEY', and 'FOOD COURT'.

DRAWN BY:	DATE:
SCALE:	JOB NUMBER:
REVISED BY:	DATE:
CAD FILENAME:	
DRAWING NUMBER:	

A-122

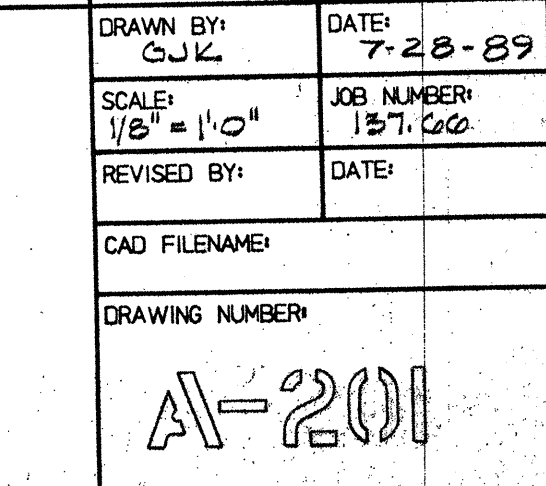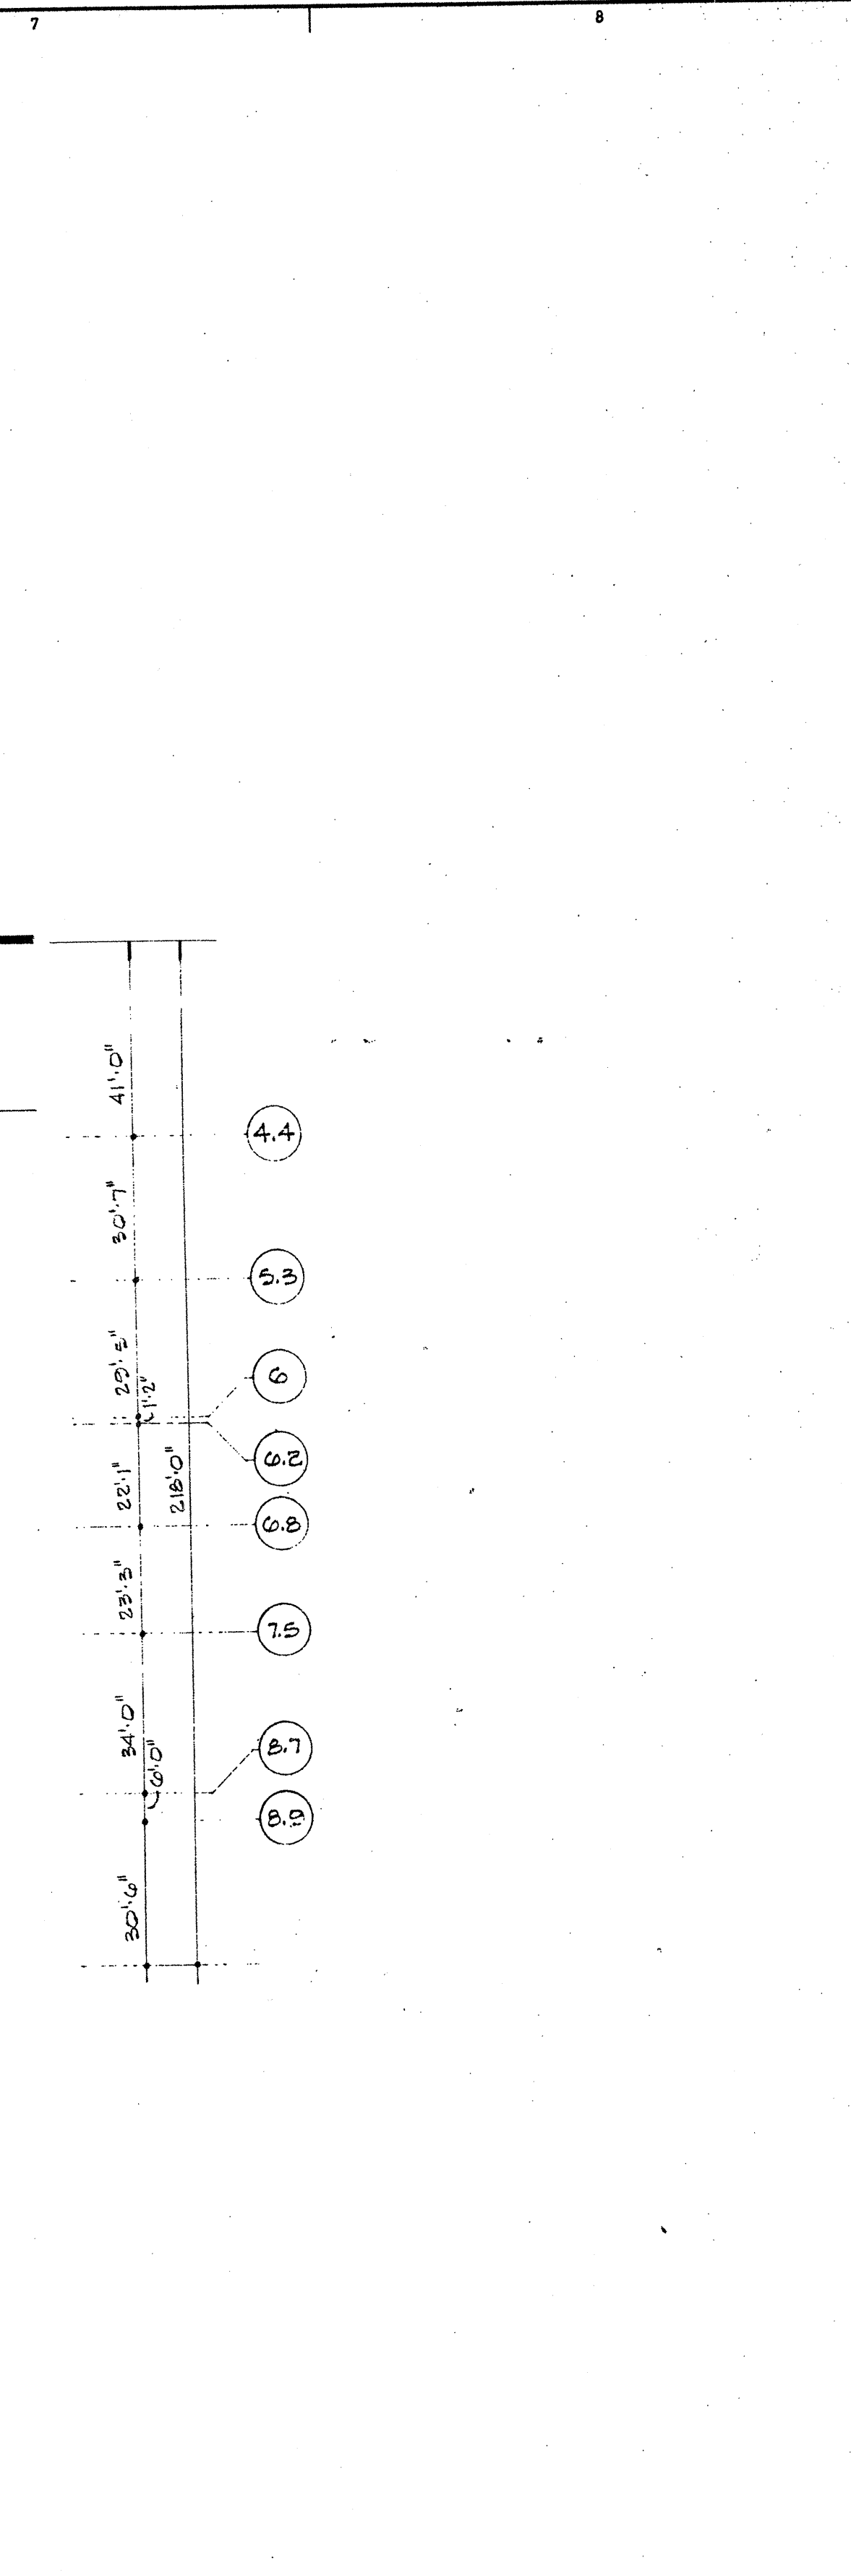

DRAWN BY: CJL	DATE: 7-28-89
SCALE: 1/8" = 1'-0"	JOB NUMBER: 137.60
REVISED BY:	DATE:
CAD FILENAME:	
DRAWING NUMBER: A-201	

JACOBS, VISCONI & JACOBS CO.
DEVELOPERS - MANAGERS



2425 CENTER HIDE ROAD
CLEVELAND, OHIO 44132
Area Code (216) 871-4800

**OVERALL MALL
REFLECTED CEILING PLAN**


**MIDWAY MALL
EXPANSION**


OHIO

ELYNRA

CENTER RIDGE DESIGN SERVICES INC. P.A.
ARCHITECTS - ENGINEERS


2505 CENTER RIDGE ROAD
CLEVELAND, OHIO 44145-02
Area Code (216) 871-4400

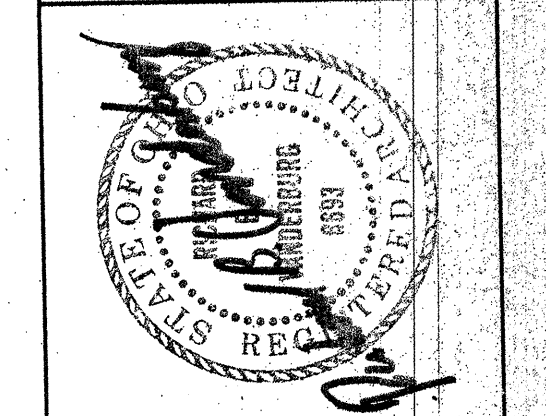[illegible]

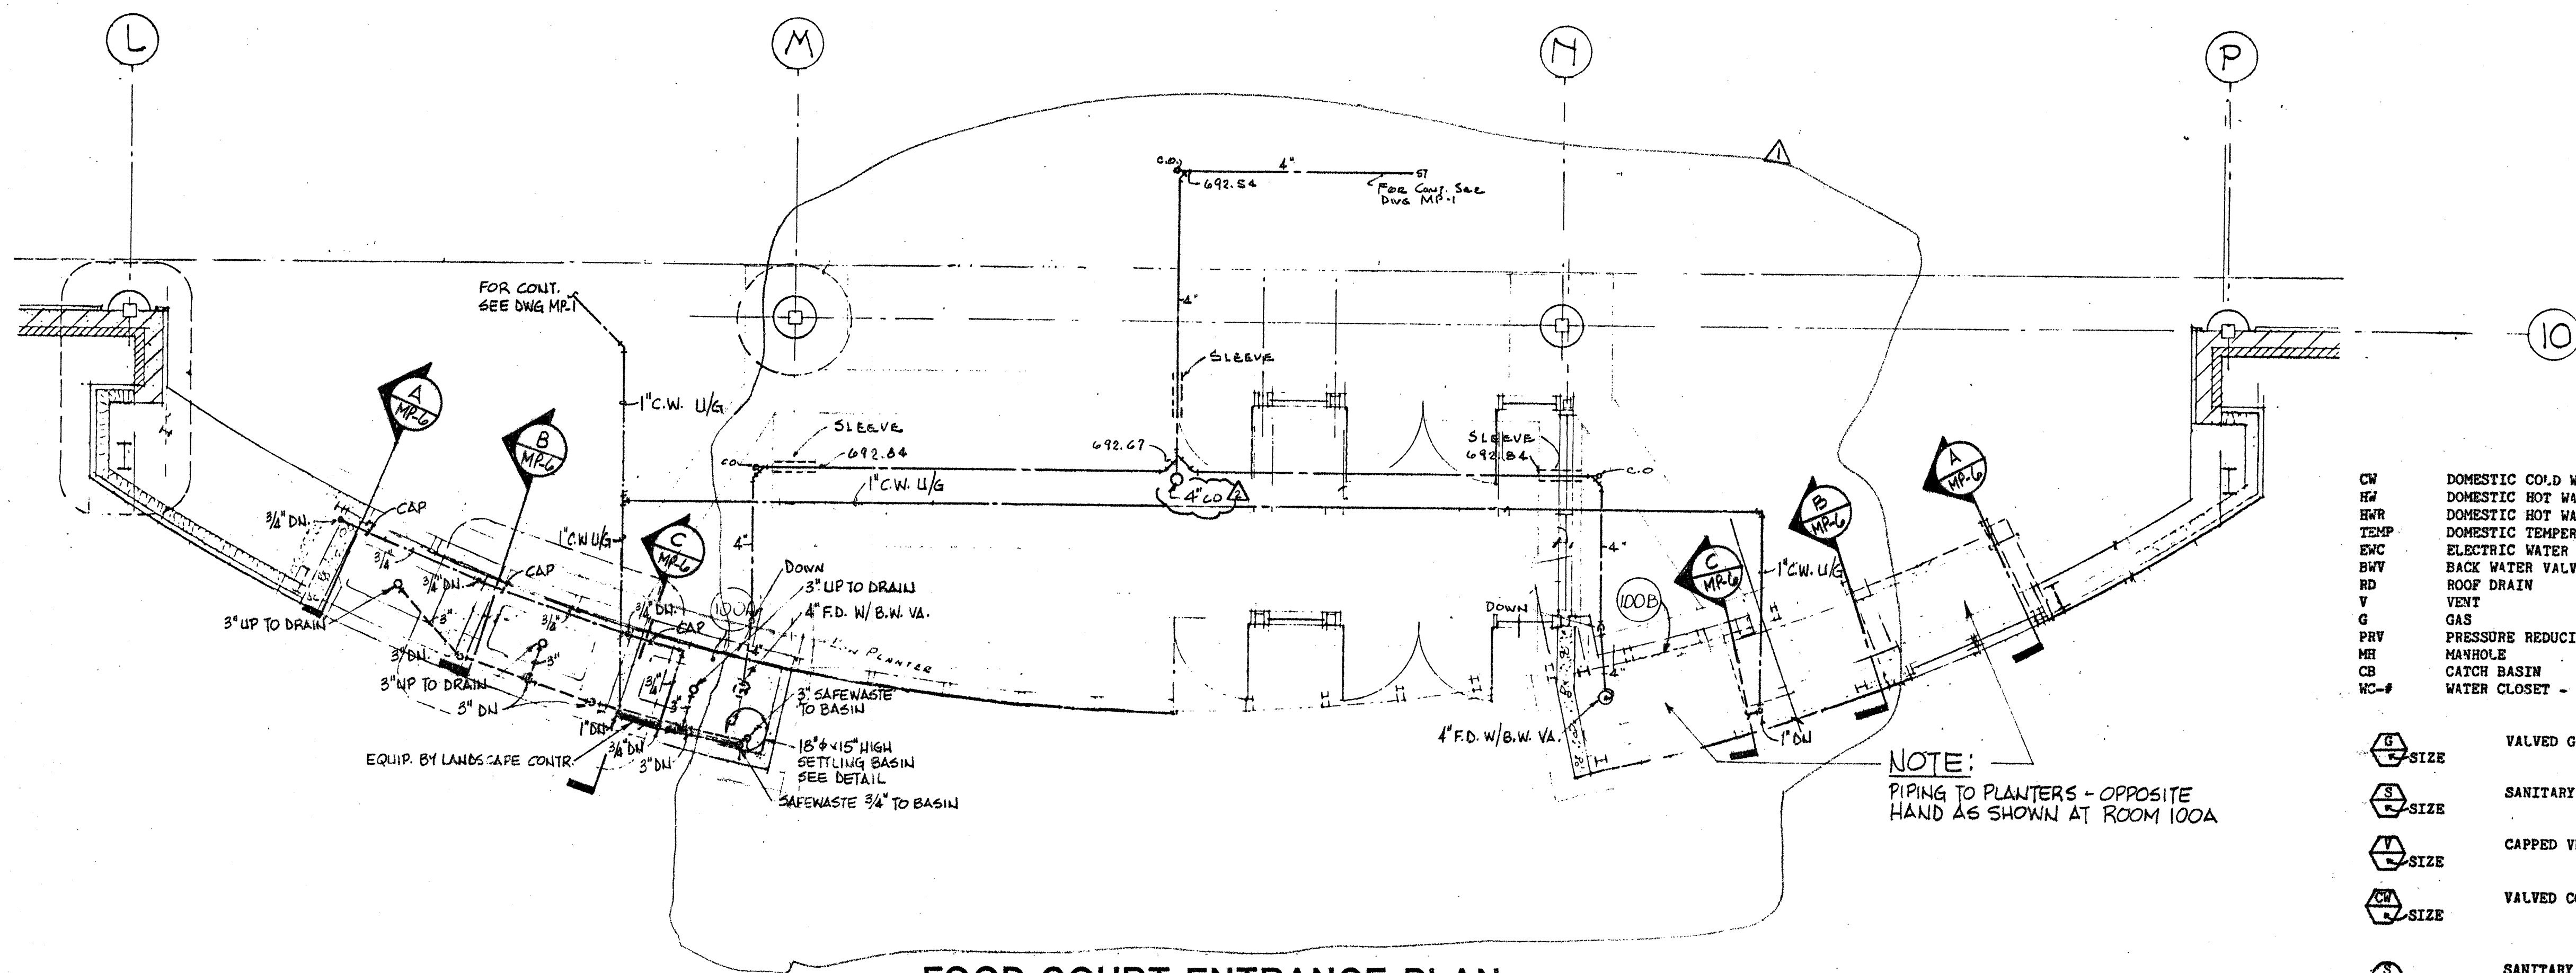

FOOD COURT ENTRANCE PLAN

SCALE: $\frac{1}{4}'' = 1'-0''$

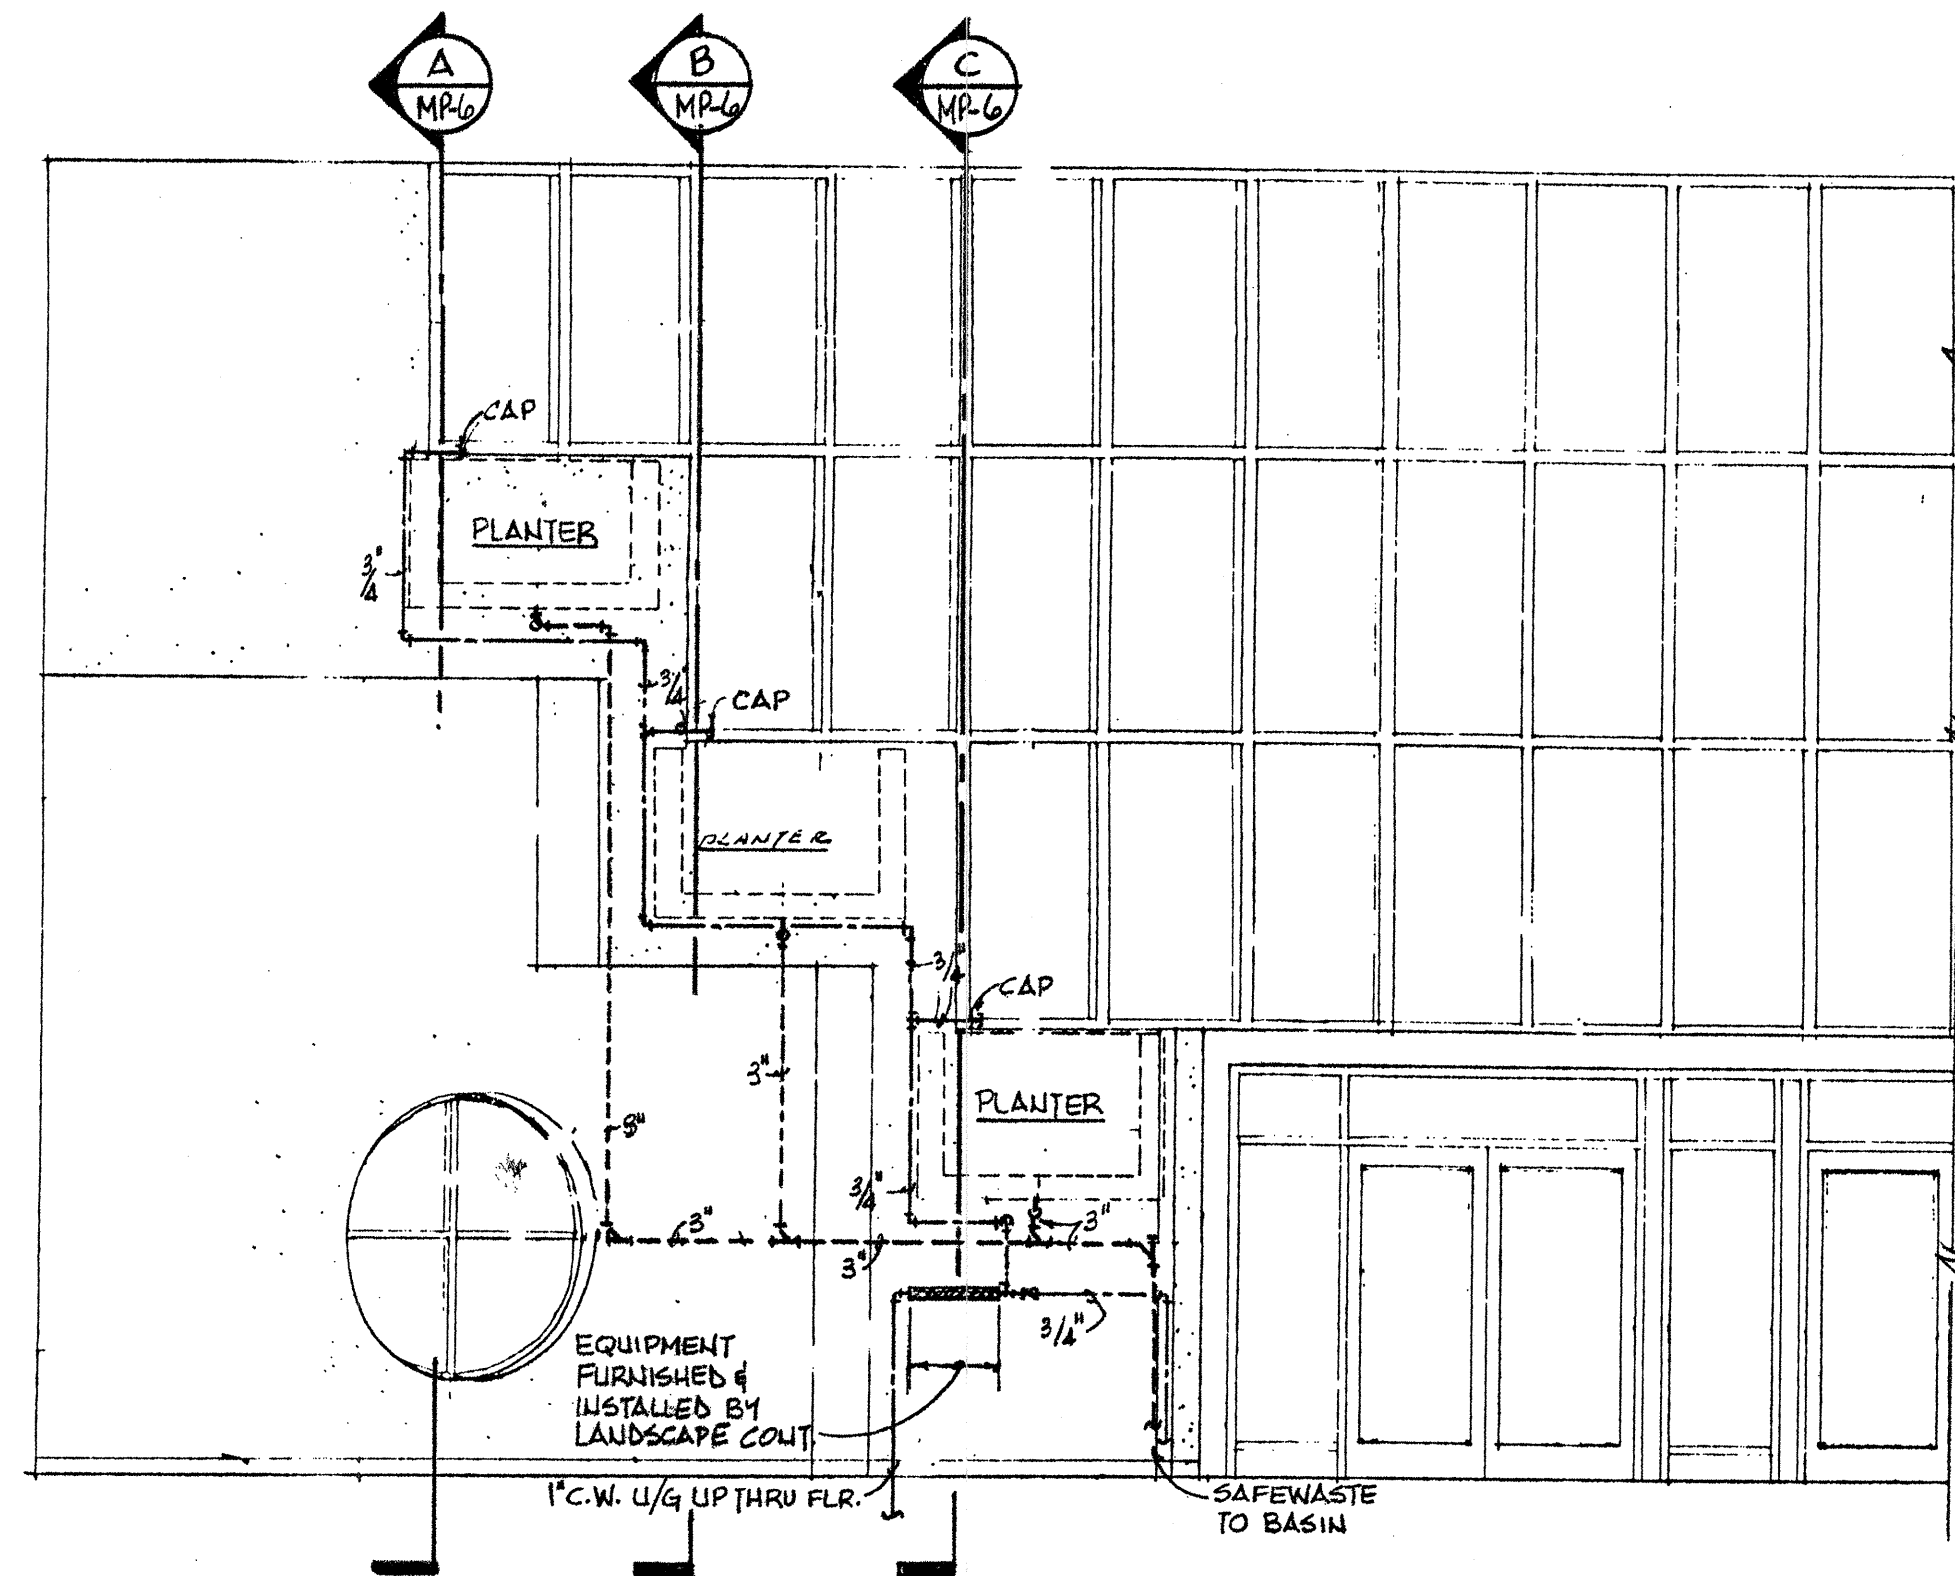


HALF ELEVATION - INTERIOR

SCALE: $\frac{1}{4}'' = 1'-0''$

NOTE: HAND WATERING PLANTERS
INDIVIDUALLY AS SHOWN
PLUMBING SHALL BE AS SHOWN
WHEN PLUMBING IS NOT SHOWN
STANDARD VALVE IS TO BE USED
INDIVIDUAL VALVE IS TO BE OPENED

WATER RIVER DIAGRAM

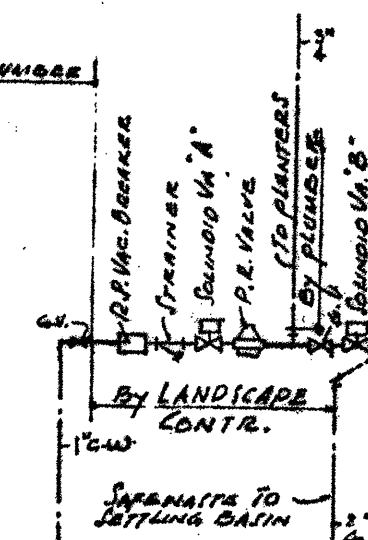


PLUMBING SYMBOLS			
CW	DOMESTIC COLD WATER	LAV-#	LAVATORY - TYPE
HW	DOMESTIC HOT WATER	VTR	VENT THROUGH ROOF
HWR	DOMESTIC HOT WATER RETURN	URN	URINAL
TEMP	DOMESTIC TEMPERED WATER	FS-#	FLOOR SINK - TYPE
EWC	ELECTRIC WATER COOLER	FD-#	FLOOR DRAIN - TYPE
BWV	BACK WATER VALVE	HD	HUB DRAIN
RD	ROOF DRAIN	IE	INVERT ELEVATION
V	VENT	HB	HOSE BIBBS
G	GAS	WH	WALL HYDRANTS
PRV	PRESSURE REDUCING VALVE	WCO	WALL CLEAN OUT
MH	MANHOLE	CO	CLEAN OUT
CB	CATCH BASIN	AFF	ABOVE FINISHED FLOOR
WC-#	WATER CLOSET - TYPE	RWC	RAIN WATER CONDUCTOR

	VALUED GAS SERVICE CONNECTION	SEE PLANS FOR SIZES
	SANITARY CONNECTION	SIZE = 4" UNLESS OTHERWISE NOTED
	CAPPED VENT CONNECTION	SIZE = 2-1/2" UNLESS OTHERWISE NOTED
	VALUED COLD WATER CONNECTION	SIZE = 1" CONNECTION WITH 3/4" VALVE UNLESS OTHERWISE NOTED
	SANITARY STACK	SIZE = 4" UNLESS OTHERWISE NOTED
/UNIT #	TENANT UNIT # WHEN USED WITH ABOVE CONNECTION	

---	DOMESTIC COLD WATER PIPING
---	DOMESTIC HOT WATER PIPING
---	DOMESTIC RECIRCULATION WATER PIPING
---	SANITARY PIPING
---	VENT PIPING
---	STORM SEWER PIPING
---	GAS PIPING
---	VALVE (SEE SPECS)
---	CHECK VALVE

REVISIONS	
ISSUED FOR BIDDING	7/3/89
REVISED STORM SEWER PIPING FOR EAST ENT. SUT. # 2	9-11-89
REVISED F.D. # ENT. TO 4" CO. ISSUED FOR BULLETIN # 4	10-11-89

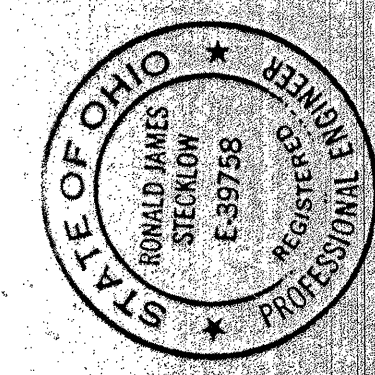


MIDWAY MALL EXPANSION
ELYNIA OHIO

CENTER RIDGE DESIGN SERVICES INC. P.A.
ARCHITECTS - ENGINEERS
2505 CENTER RIDGE ROAD
CLEVELAND, OHIO 44115
NEW YORK, NY 10017

PLUMBING PLANS
FOOD COURT ENTRANCE

JACOBS, VISCONSI & JACOBS CO.
DEVELOPERS - MANAGERS
2505 CENTER RIDGE ROAD
CLEVELAND, OHIO 44115
NEW YORK, NY 10017

Stecklow & Assoc. Company, P.A.
CONSULTING ENGINEERS
24600 Center Ridge Road Suite 160
Cleveland, Ohio 44145 (216) 835-0230

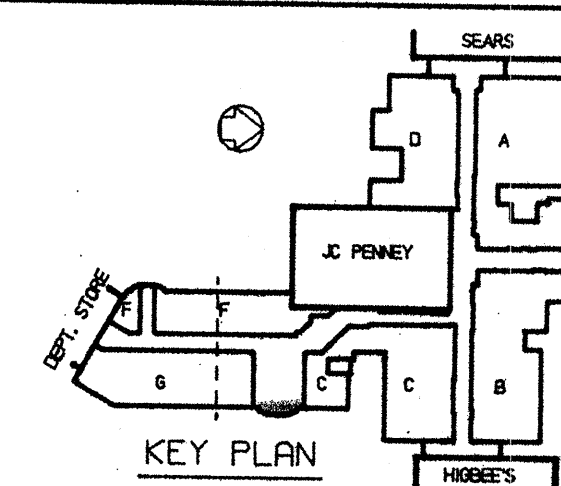

DRAWN BY: KDA	DATE: 7/3/89
SCALE: AS NOTED	JOB NUMBER: 137.66
REVISED BY: A	DATE: 10-11-89
CAD FILENAME:	
DRAWING NUMBER	MP-5