


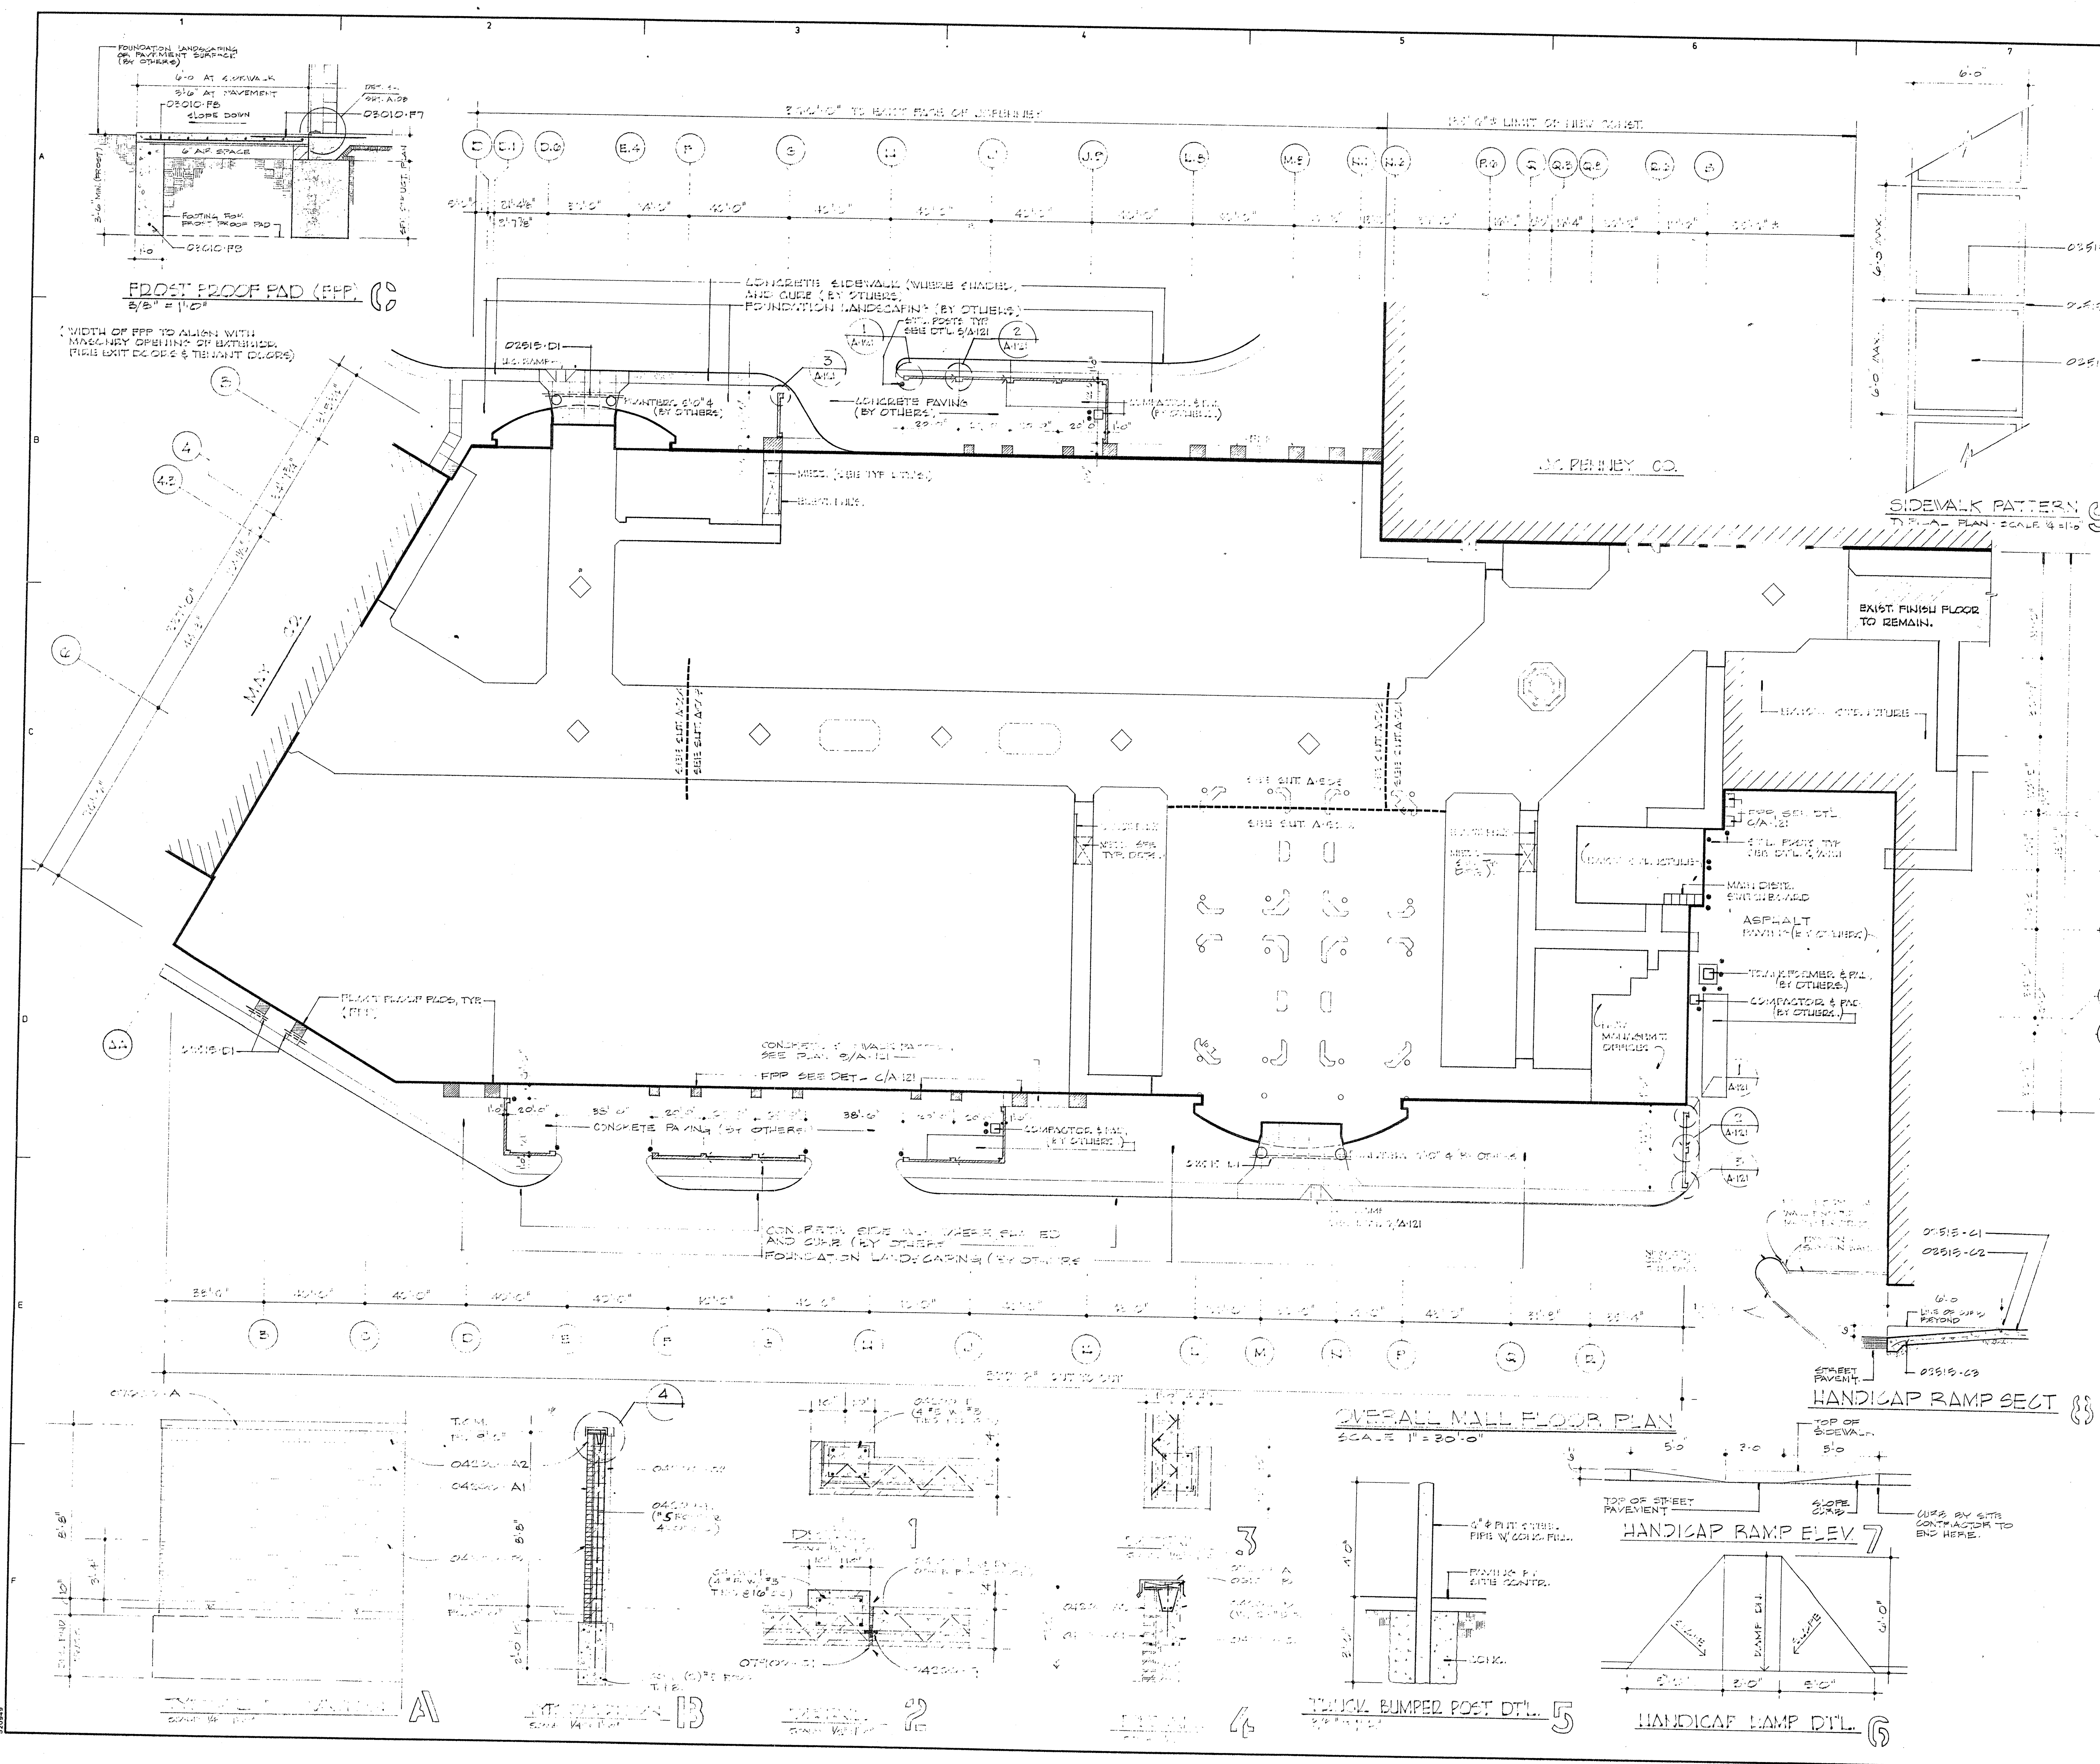

REVISIONS

BULLETIN No. 4
12-11-88

KEYNOTE SYSTEM ON DRAWINGS

A keynoting system is used on the architectural drawings for material references and notes. Refer to the keynote legend on the drawing for the information which relates to each keynote on that respective drawing.

Each keynote consists of a 5-digit number followed by a period and a letter or letter/number suffix. The 5-digit number relates to the specification section which generally covers the item that is referenced and the suffix identifies the specific reference notation used on the drawings. The suffix does not relate to any corresponding reference letter in the specifications.

THE ORGANIZATION OF THE KEYNOTING SYSTEM ON THE DRAWINGS, WITH THE KEYNOTE REFERENCE NUMBERS RELATED TO THE SPECIFICATIONS SECTIONS NUMBERING SYSTEM, SHALL NOT CONTROL THE GENERAL CONTRACTOR IN DIVIDING THE WORK AMONG ITS SUBCONTRACTORS OR IN ESTABLISHING THE EXTENT OF WORK TO BE PERFORMED BY ANY ONE TRADE.

DIVISION 2 - PORTLAND CEMENT CONCRETE PAVING

02515 - 01 Tooled Construction Joint or Control Joint.
02515 - 02 Trowel Edges.
02515 - 03 Broom Finish.
02515 - 04 4" Concrete Sidewalk.
02515 - 05 Tooled Control Joint.
02515 - 06 5" Thick Concrete Ramp with 3" x 6" x 10" #10 W/W on 4" Granular Fill on Well Compacted Earth.
02515 - 07 6" Underground Sleeve, PVC 160 #20 26" Elevation and Gravel Bed as Required by Landscape Architect.

DIVISION 3 - CONCRETE

03010 - F7 #4, 4'-0" at 12" o.c., Existing bowled out.
03010 - F8 4" Concrete Slab with #4's at 9" o.c. Each Way (Bottom) on 26 GA. Centering.
03010 - F9 #5, Top and Bottom, Drill and Grout into Existing Footing.

DIVISION 4 - MASONRY

04200 - A1 Project face brick (running bond), see specifications.
04200 - A2 Project face brick (soldier course), see specifications.
04200 - B Accent face brick, see specifications.
04200 - C2 Concrete block (paint to match face brick).
04200 - D Bond beam.
04200 - E Masonry wall reinforcing rods (see drawings for size, length and spacing).
04200 - F Masonry wall reinforcing at every other block course, see specifications.
04200 - G Rubber control joint material (prefabricated).

DIVISION 6 - WOOD & PLASTICS

06100 - B Continuous treated wood nailer with 1/2" diameter x 18" long anchor bolts (staggered at 4'-0" o.c.).

DIVISION 7 - THERMAL & MOISTURE PROTECTION

07600 - A Pre-finished aluminum coping cap (finish of flashing to match project face brick).
07900 - C1 Joint sealant for exterior masonry walls.

MIDWAY MALL EXPANSION

OHIO
ELYRIA

CENTER RIDGE DESIGN SERVICES INC. P.A.
ARCHITECTS - ENGINEERS
2625 CENTER RIDGE ROAD
CLEVELAND, OHIO 44130-02
PH: 216 764-4400

**OVERALL MALL FLOOR PLAN
SCREEN WALLS & DETAILS**

JACOBS, VISCONI & JACOBS CO.

DEVELOPERS - MANAGERS

2625 CENTER RIDGE ROAD
CLEVELAND, OHIO 44130-02
PH: 216 764-4400

**OVERALL MALL FLOOR PLAN
SCALE: 1" = 20'-0"**

HANDICAP RAMP SECT

HANDICAP RAMP ELEV. 7

HANDICAP RAMP DTL.

TRUCK BUMPER POST DTL.

KEY PLAN


DRAWN BY: DATE: 7-28-89

SCALE: AS NOTED JOB NUMBER: 100-0000

REVISED BY: DATE: 12-11-88

CAD FILENAME:

DRAWING NUMBER: A-121

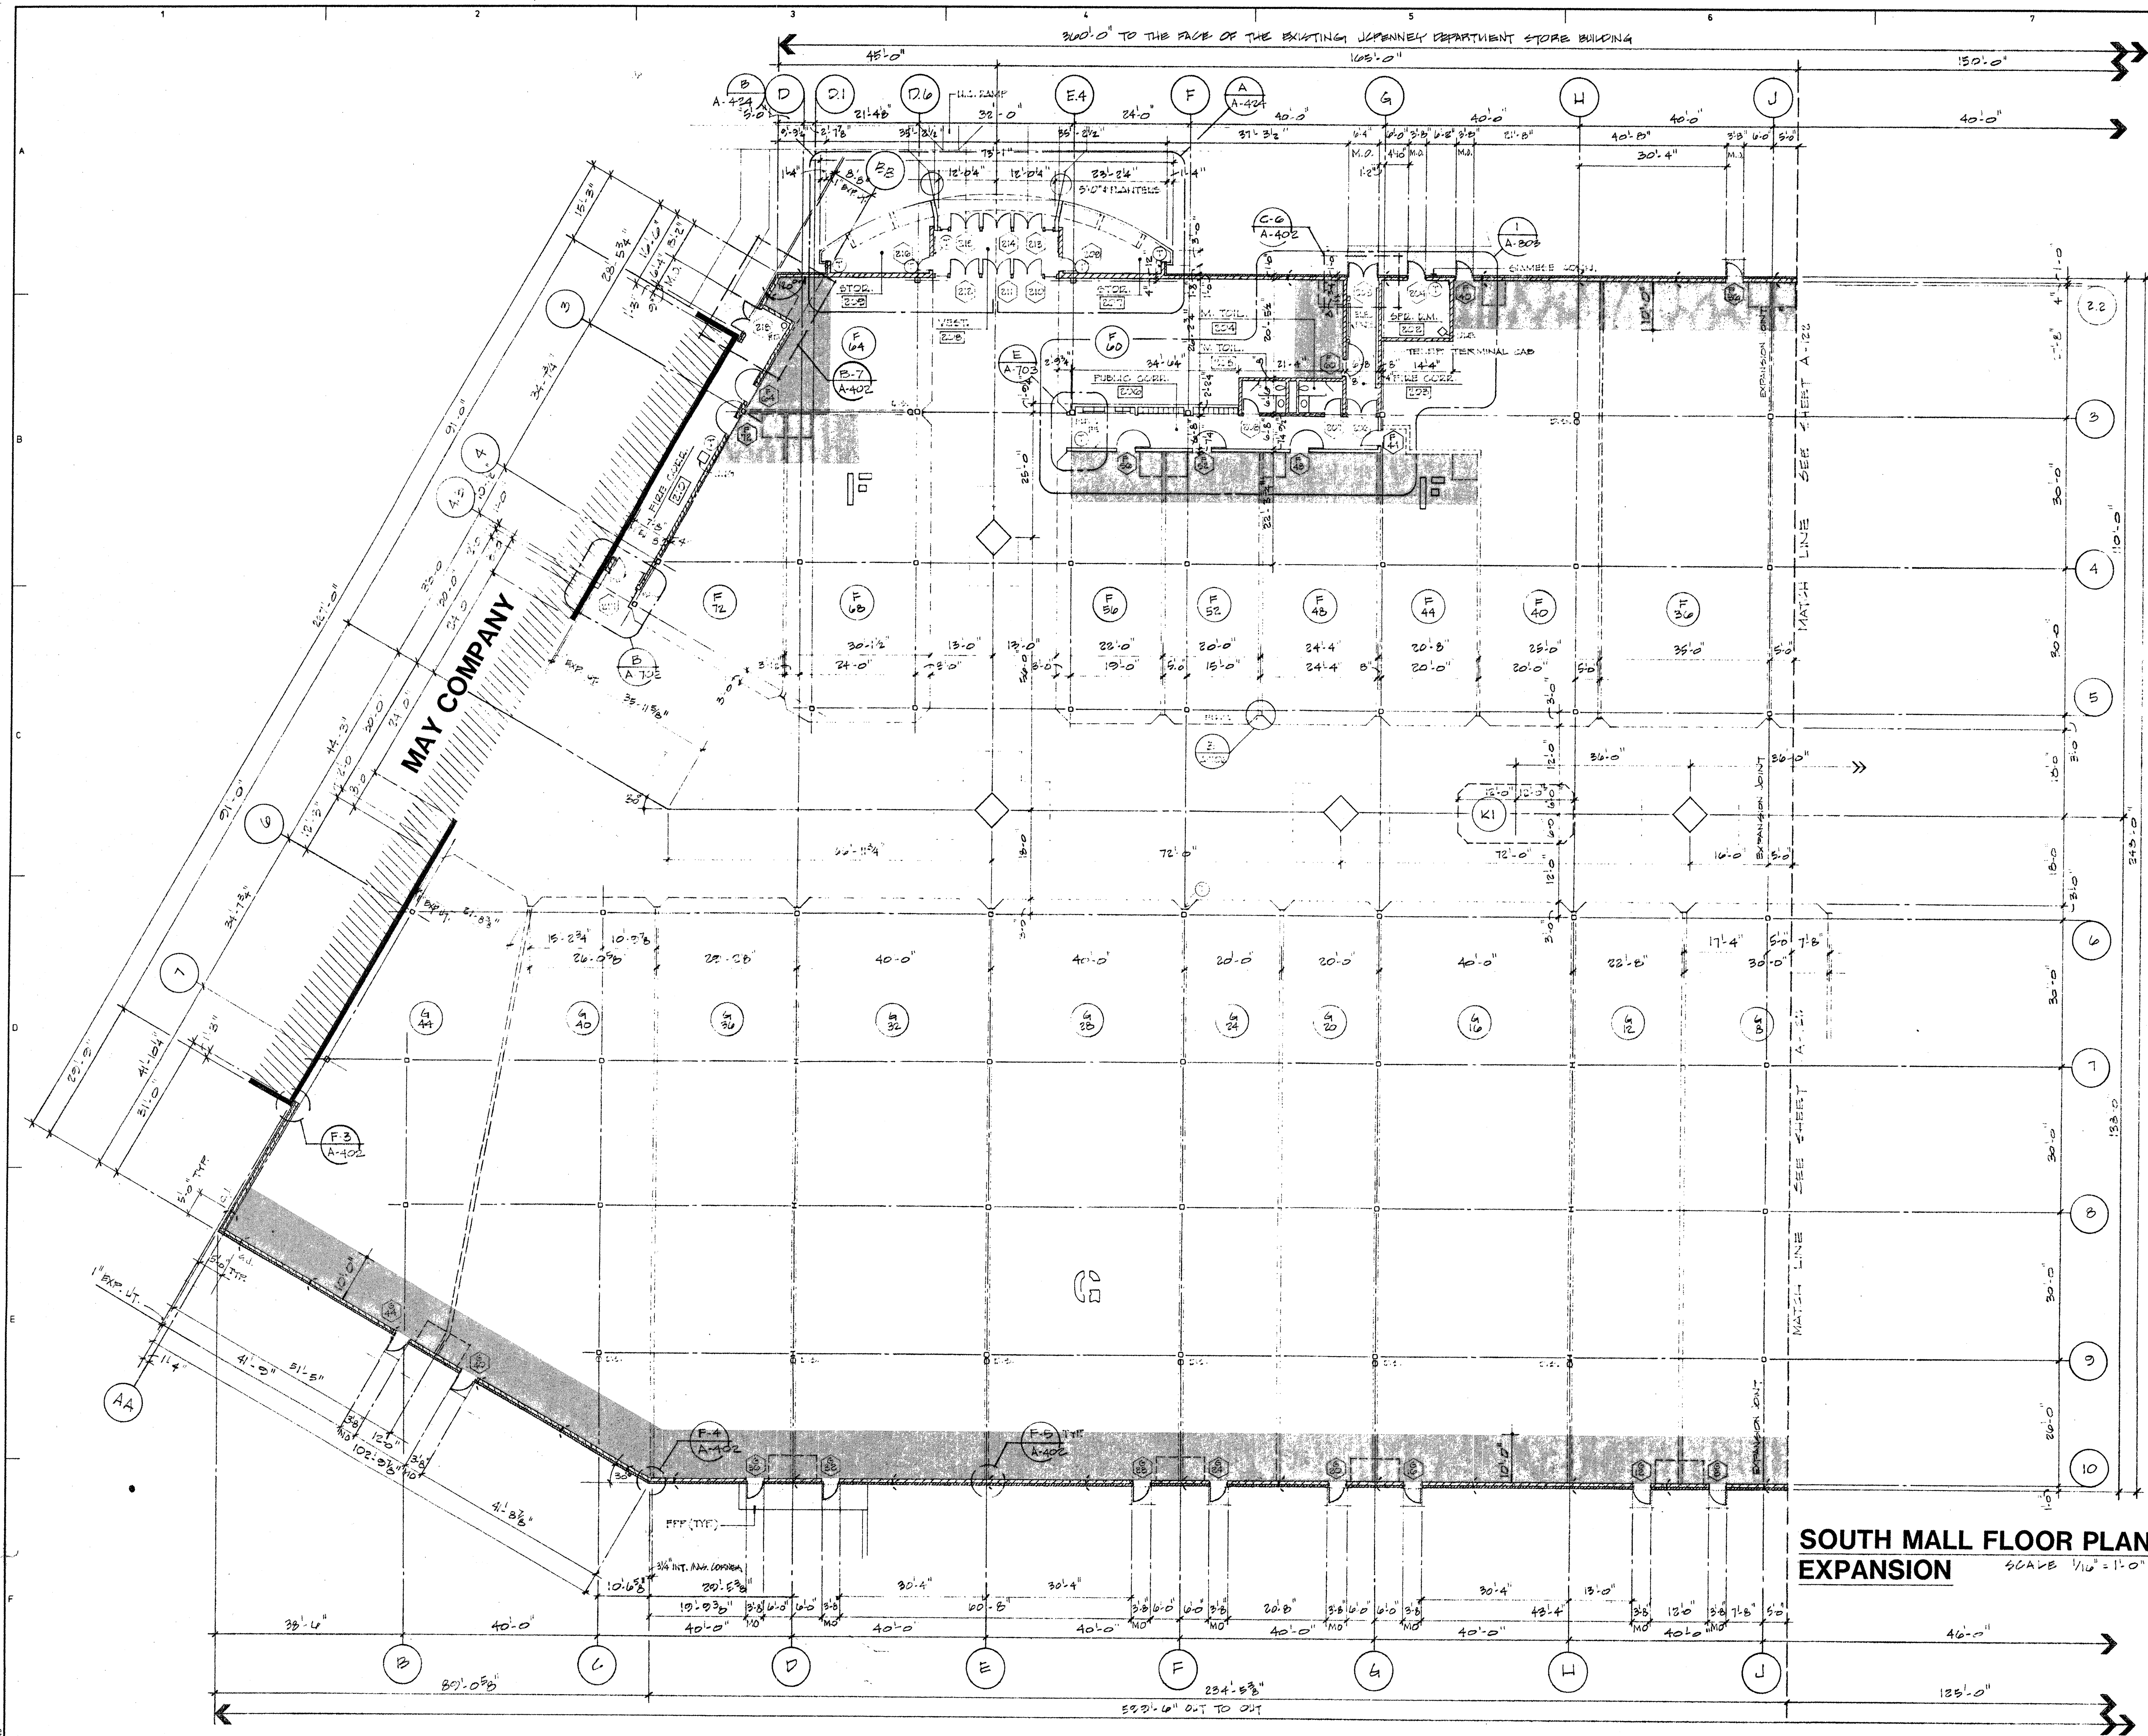

KEYNOTE SYSTEM ON DRAWINGS

A keynoting system is used on the architectural drawings for material references and notes. Refer to the keynote legend on the drawing for the information which relates to each keynote on that respective drawing.

Each keynote consists of a 5-digit number followed by a period and a letter or letter/number suffix. The 5-digit number relates to the specification section which generally covers the item that is referenced and the suffix identifies the specific reference notation used on the drawings. The suffix does not relate to any corresponding reference letter in the specifications.

THE ORGANIZATION OF THE KEYNOTING SYSTEM ON THE DRAWINGS, WITH THE KEYNOTE REFERENCE MARKS RELATED TO THE SPECIFICATIONS SECTIONS NUMBERING SYSTEM, SHALL NOT CONTROL THE GENERAL CONTRACTOR IN DIVIDING THE WORK AMONG ITS SUBCONTRACTORS OR IN ESTABLISHING THE EXTENT OF WORK TO BE PERFORMED BY ANY ONE TRADE.

REVISIONS

BULLETIN No. 4
10-11-80

SW

MIDWAY MALL
EXPANSION
ELVIRA


CENTER RIDGE DESIGN SERVICES INC. P.A.
ARCHITECTS - ENGINEERS
2525 CENTER RIDGE ROAD
CLEVELAND, OHIO 44122-0202
PH: 216.881.8700

SOUTH MALL FLOOR PLAN
BUILDINGS 'F' AND 'G'

JACOBS, VISONSI & JACOBS CO.
DEVELOPERS - MANAGERS
2525 CENTER RIDGE ROAD
CLEVELAND, OHIO 44122-0202
PH: 216.881.8700

DRAWN BY: DATE: 7-28-89
SCALE: JOB NUMBER: 137-66
REVISED BY: DATE: 10-11-80
CAD FILENAME:
DRAWING NUMBER:


A-123

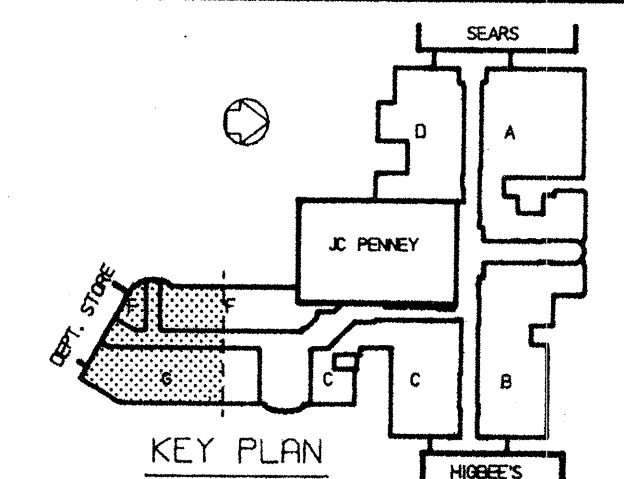


- PLUMBING SYMBOLS
- | | | | |
|------|---------------------------|-------|----------------------|
| CW | DOMESTIC COLD WATER | LAV-# | LAVATORY - TYPE |
| HW | DOMESTIC HOT WATER | VTR | VENT THROUGH ROOF |
| HWR | DOMESTIC HOT WATER RETURN | URN | URINAL |
| TEMP | DOMESTIC TEMPERED WATER | FS-# | FLOOR SINK - TYPE |
| EW | ELECTRIC WATER COOLER | FD-# | FLOOR DRAIN - TYPE |
| BWV | BACK WATER VALVE | HD | HUB DRAIN |
| RD | ROOF DRAIN | IE | INVERT ELEVATION |
| V | VENT | HB | HOSE BIBBS |
| G | GAS | WH | WALL HYDRANTS |
| PRV | PRESSURE REDUCING VALVE | WCO | WALL CLEAN OUT |
| MH | MANHOLE | CO | CLEAN OUT |
| CB | CATCH BASIN | AFP | ABOVE FINISHED FLOOR |
| WC-# | WATER CLOSET - TYPE | RWC | RAIN WATER CONDUCTOR |

- | | | |
|--------|---|---|
| SIZE | VALVED GAS SERVICE CONNECTION | SEE PLANS FOR SIZES |
| SIZE | SANITARY CONNECTION | SIZE = 4" UNLESS OTHERWISE NOTED |
| SIZE | CAPPED VENT CONNECTION | SIZE = 2-1/2" UNLESS OTHERWISE NOTED |
| SIZE | VALVED COLD WATER CONNECTION | SIZE = 1" CONNECTION WITH 3/4" VALVE UNLESS OTHERWISE NOTED |
| SIZE | SANITARY STACK | SIZE = 4" UNLESS OTHERWISE NOTED |
| UNIT # | TENANT UNIT # WHEN USED WITH ABOVE CONNECTION | |
-
- | | |
|-----|-------------------------------------|
| --- | DOMESTIC COLD WATER PIPING |
| --- | DOMESTIC HOT WATER PIPING |
| --- | DOMESTIC RECIRCULATION WATER PIPING |
| --- | SANITARY PIPING |
| --- | VENT PIPING |
| --- | STORM SEWER PIPING |
| --- | GAS PIPING |
| --- | VALVE (SEE SPECS) |
| --- | CHECK VALVE |

FF ELEVATION = 696.15 (REFERENCE)

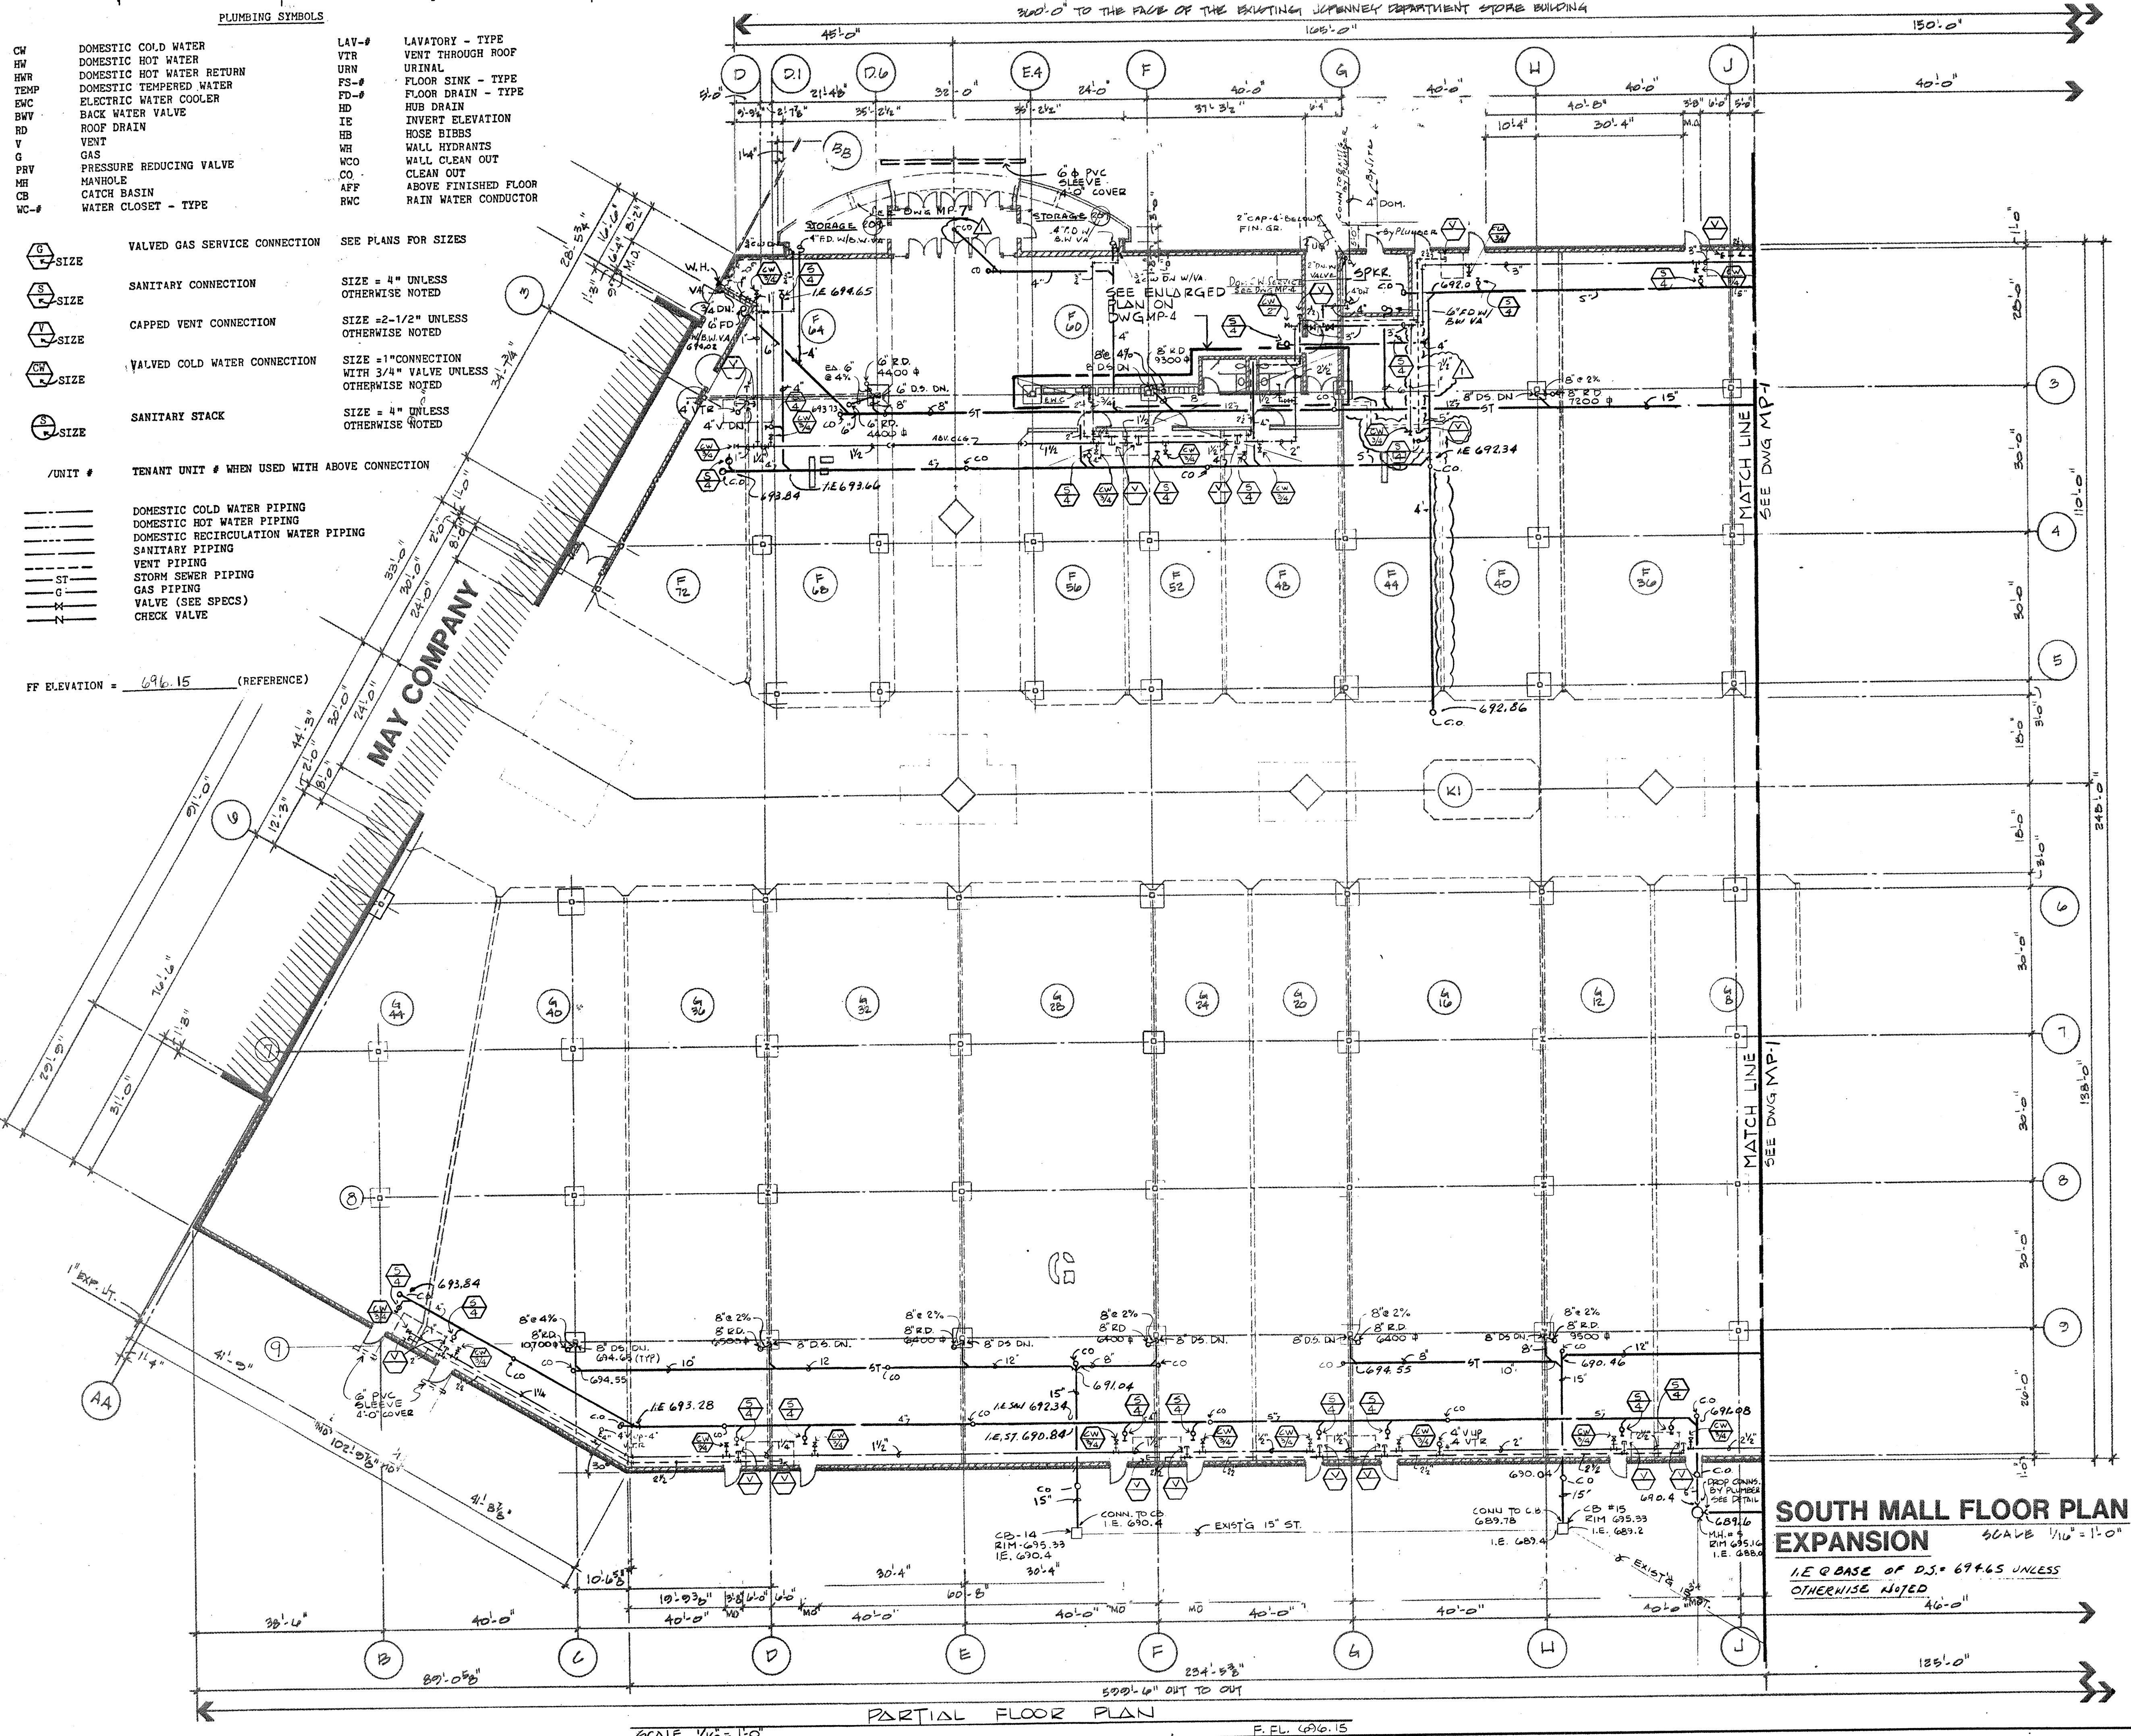

SOUTH MALL FLOOR PLAN EXPANSION
SCALE 1/16" = 1'-0"
I.E. Q BASE OF D.S. = 694.65 UNLESS OTHERWISE NOTED

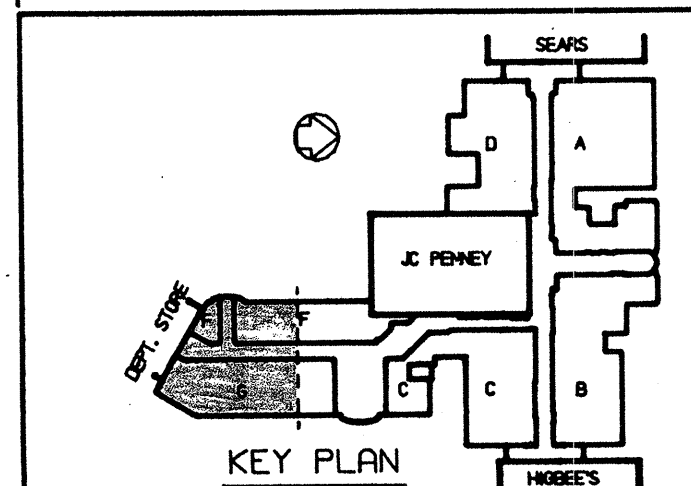

REVISIONS ISSUED FOR BIDDING 7/3/89 REVISE ARCHITECTURE 200' GROUND TO UNIT F. 40 & F. 44, ADDED SERVICES TO UNIT F. 44. REVISE 4" FD @ ENT. TO 4" CO. ISSUED FOR BULLETIN #4 10-11-89											
MIDWAY MALL EXPANSION ELYRIA, OHIO	CENTER RIDGE DESIGN SERVICES INC. P.A. ARCHITECTS - ENGINEERS 2450 CENTER RIDGE ROAD CLEVELAND, OHIO 44115 AND ONE ONE EIGHT										
SOUTH MALL PLUMBING PLAN BUILDINGS 'F' AND 'G'	JACOBS, VISCONSI & JACOBS CO. DEVELOPERS - MANAGERS 2450 CENTER RIDGE ROAD CLEVELAND, OHIO 44115 AND ONE ONE EIGHT										
Stecklow & Assoc. Company, P.A. CONSULTING ENGINEERS 24500 Center Ridge Road, Suite 100 Cleveland, Ohio 44145 (216) 835-0230	<table><tr><td>DRAWN BY: SC</td><td>DATE: 7/3/89</td></tr><tr><td>SCALE: AS NOTED</td><td>JOB NUMBER: 137.66</td></tr><tr><td>REVISED BY: A</td><td>DATE: 10/11/89</td></tr><tr><td>CAD FILENAME:</td><td></td></tr><tr><td>DRAWING NUMBER:</td><td>MP-2</td></tr></table>	DRAWN BY: SC	DATE: 7/3/89	SCALE: AS NOTED	JOB NUMBER: 137.66	REVISED BY: A	DATE: 10/11/89	CAD FILENAME:		DRAWING NUMBER:	MP-2
DRAWN BY: SC	DATE: 7/3/89										
SCALE: AS NOTED	JOB NUMBER: 137.66										
REVISED BY: A	DATE: 10/11/89										
CAD FILENAME:											
DRAWING NUMBER:	MP-2										